



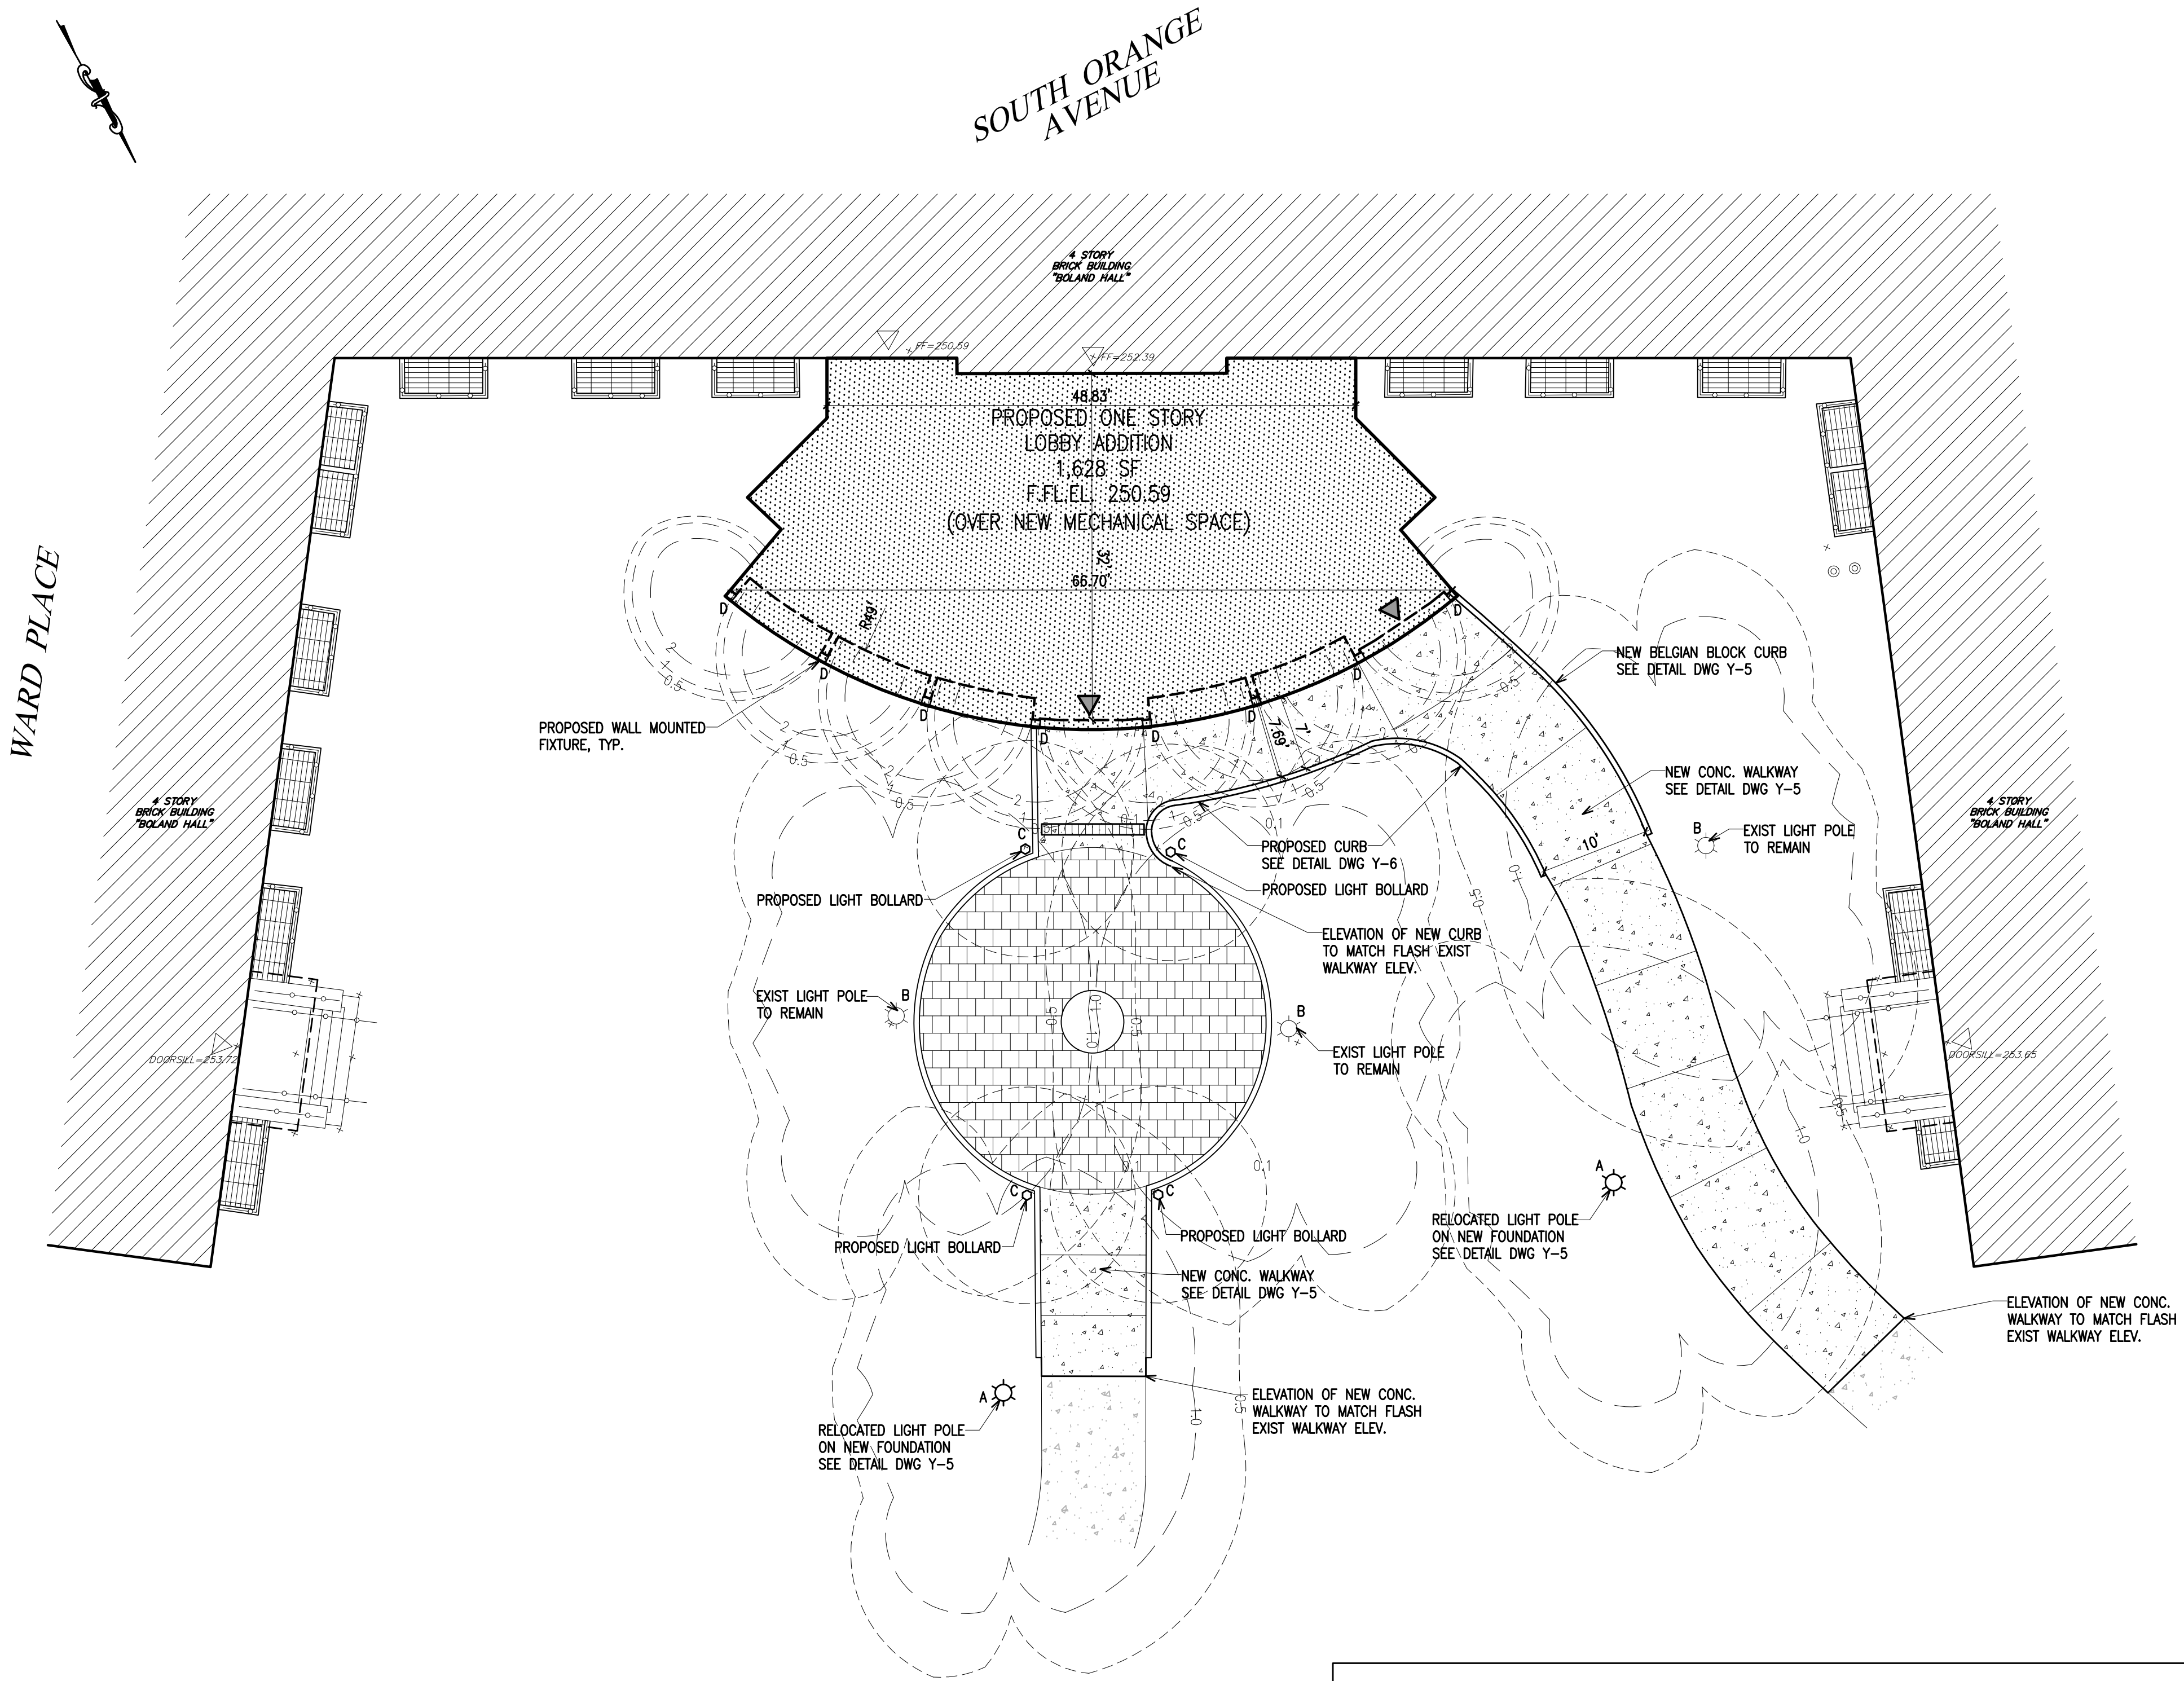


SITE PLAN
SCALE: 1"=10'


SITE LIGHTING SCHEDULE						
SYMBOL	KEY	QTY.	MODEL	MOUNTING HEIGHT	LAMP WATTAGE	LAMP SOURCE
☼	A	2	RELOCATED LIGHT POLE ON NEW FOUNDATION F360 SHU BOULEVARD 1000	12'	150 W	PULSE START METAL HALIDE
☼	B	3	EXISTING LIGHT POLE F360 SHU BOULEVARD 1000	12'	150 W	PULSE START METAL HALIDE
○	C	4	PROPOSED LIGHT BOLLARD ESSEX BOLLARD-PennSTAR® LED	42"	30 W	LED
□	D	8	PROPOSED LED WALL-MOUNT SQUARE SCONE MODEL #33 592 BY BEGA	8'	15.8 W	LED

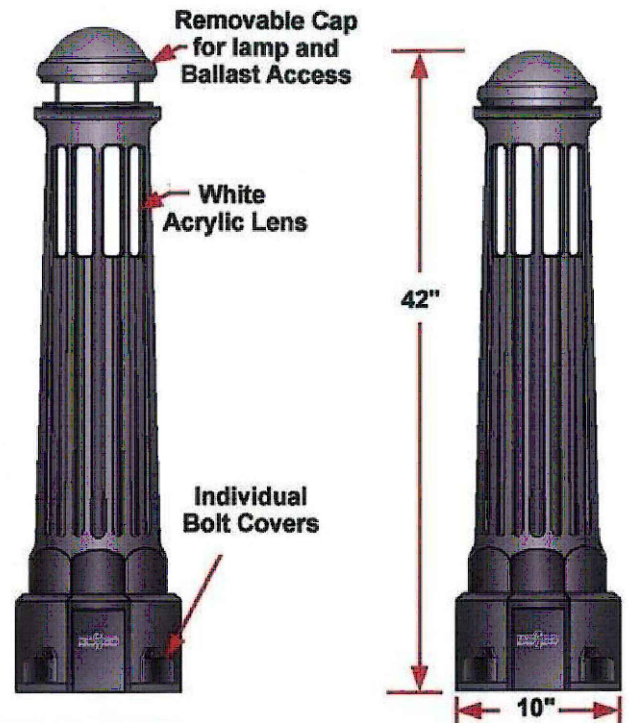

LIGHT BOLLARD DETAIL
SCALE: N.T.S.
(FOR LOCATION SEE PLAN)
COLOR TO BE BLACK

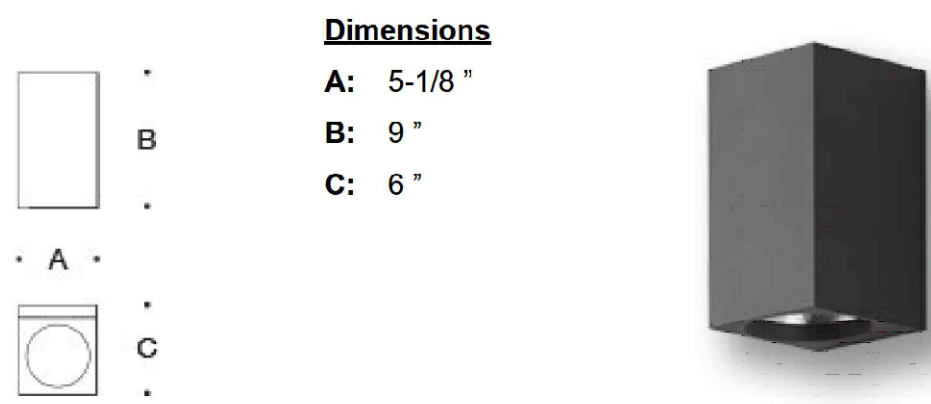

BEGA WALL LUMINAIRE DETAIL
SCALE: N.T.S.
(FOR LOCATION SEE PLAN)
COLOR TO BE BLACK

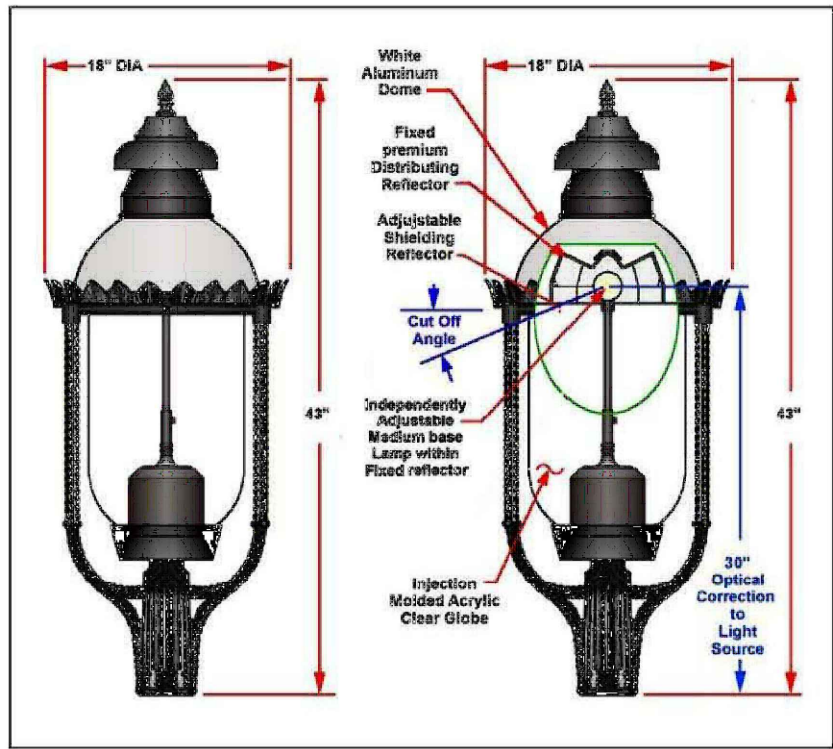


EXISTING SETON HALL LIGHT FIXTURE
SCALE: N.T.S.
(FOR LOCATION SEE PLAN)

LEGEND

EXISTING	PROPOSED
PROPERTY LINE	---
BUILDING SETBACK	---
DRAINAGE PIPE	—D—
CATCH BASIN	□
DRAINAGE M.H.	⊕
SANITARY SEWER LINE	—S—
SANITARY SEWER M.H.	⊙
WATER MAIN LINE	—W—
FIRE LINE	—F—
IRRIGATION MAIN	—I—
TELEPHONE MAIN	—T—
ELECTRIC LINE	—E—
TEL. & ELEC. LINE	—T-E—
GAS MAIN LINE	—G—
SPRINKLER	•
FIRE HYDRANT	⊗
WATER VALVE	⊗
PAVEMENT	▨
CONCRETE CURB	—C—
SPOT ELEVATION	+10.0'
LIGHT POLE	○
I.E.	•
T.G.	•

Revisions		
Date	Issue	Description
11-02-20	A	FOR CLIENT'S REVIEW
11-16-20	B	PROGRESS PRINTS ISSUED FOR SHU REVIEW
11-24-20	C	REVISED PER CLIENT'S COMMENTS
12-08-20	D	FOR PLANNING BOARD FILING AND APPROVAL
01-13-21	E	ADDED LIGHTING INFORMATION

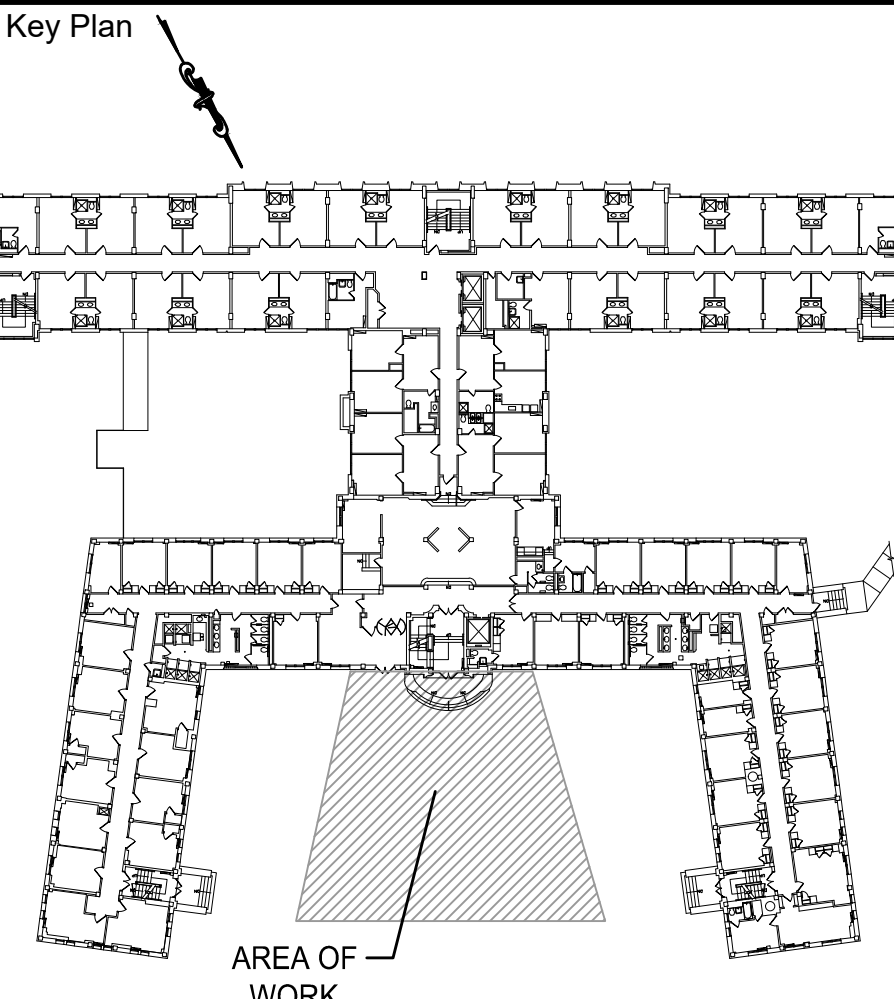

Consultants

Project
SETON HALL UNIVERSITY
BOLAND HALL
ENTRANCE LOBBY ADDITION

400 SOUTH ORANGE AVENUE
BLOCK No. 901 LOT No. 3
SOUTH ORANGE, NEW JERSEY 07079
PHONE: (973) 761-9000



SETON HALL UNIVERSITY
400 SOUTH ORANGE AVENUE
SOUTH ORANGE, NEW JERSEY
PHONE: (973) 761-9000



Architects & Engineers, P.C.
1 PARAGON DRIVE • MONTVALE • NEW JERSEY, 07845
TEL: 201.578.1787 FAX: 201.578.0808 www.sns-arch-eng.com

John M. Lignos, AIA ○
Lorin J. Sonenshine, AIA ○
Steven Napolitano, PE ●
Robert G. Nocella, AIA ○

Cert./Lic. No. 41989
Date 10-12-20 Scale AS NOTED
Drawn By AS Checked By SN
Dwg. Title

PROPOSED SITE PLAN
Work Order No. Dwg. No.

5361 Y-3

