
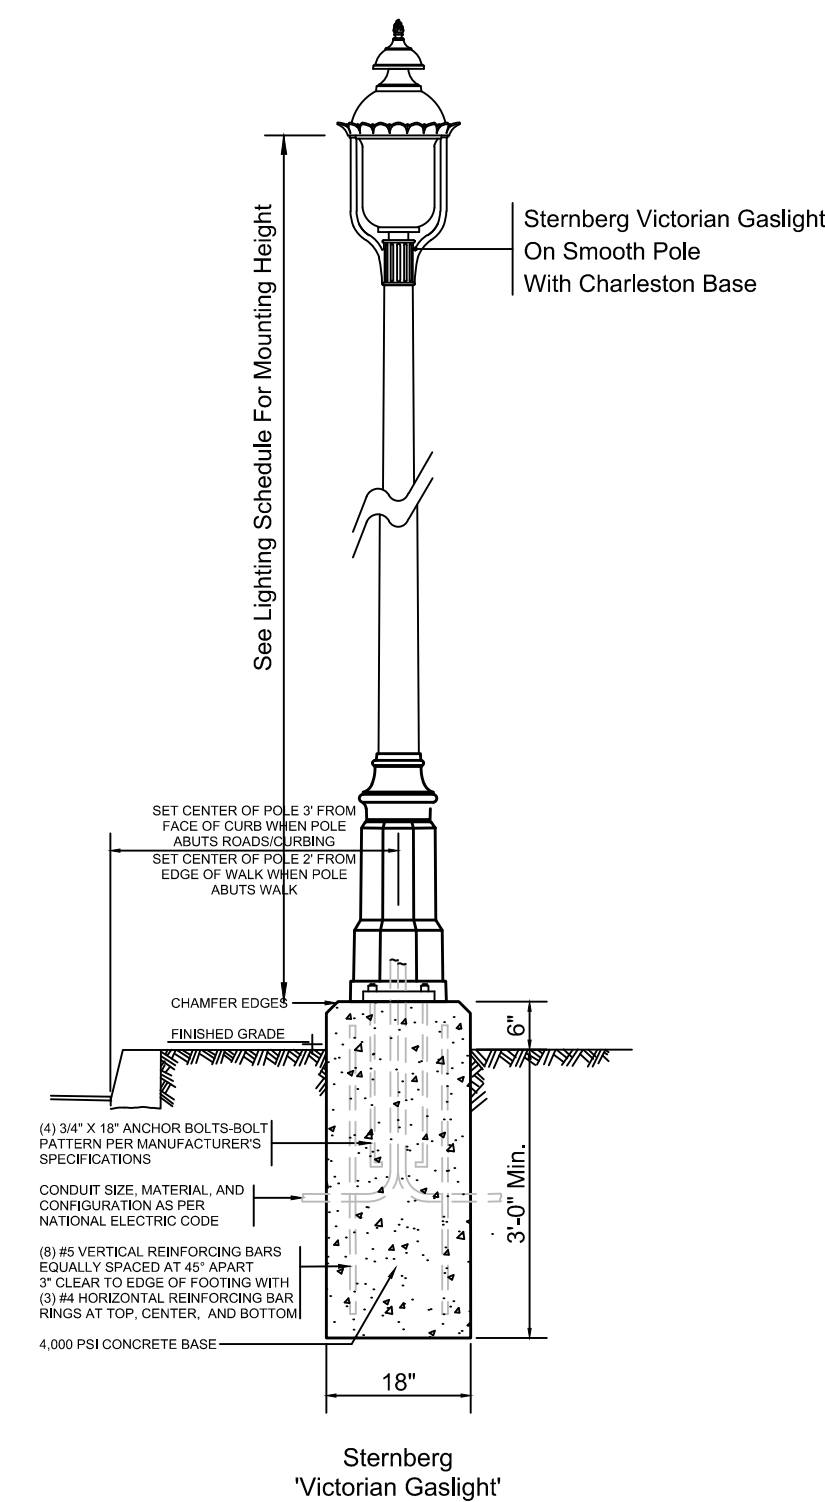


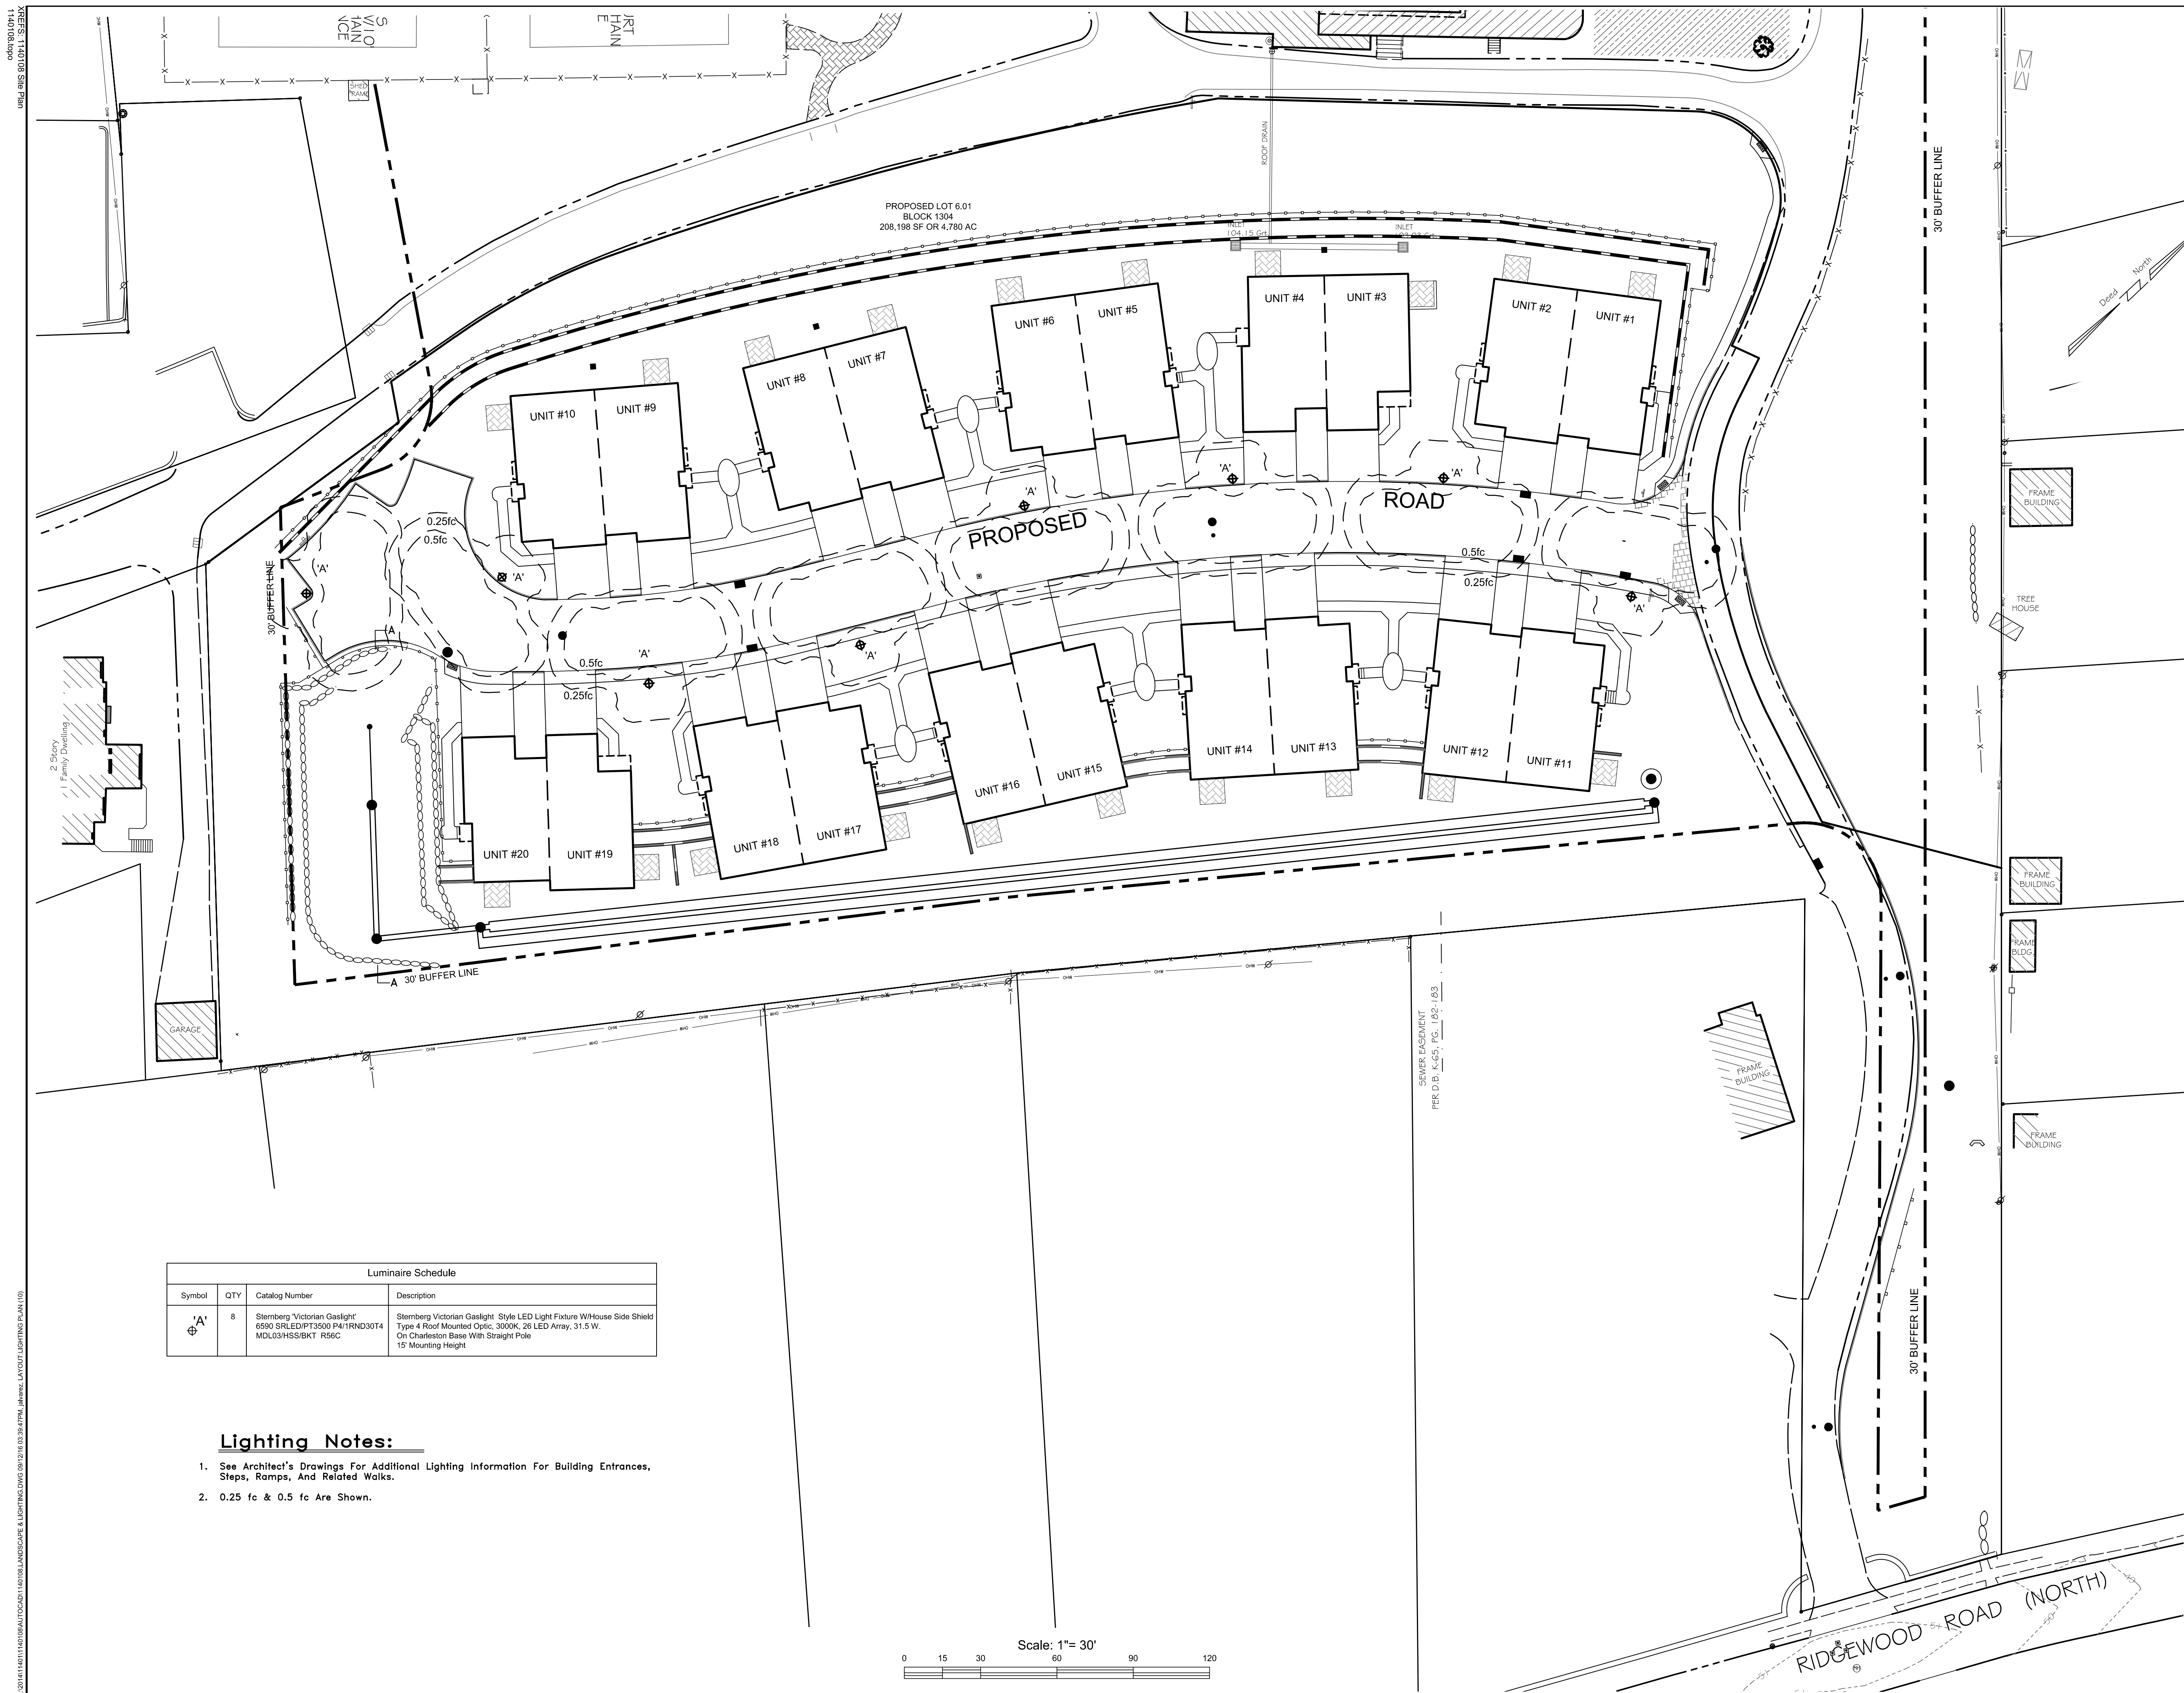


A Lighting Detail

LIGHTING PLAN

305 RIDGEWOOD ROAD NORTH
TAX LOT 6, BLOCK 1304

TOWNSHIP OF SOUTH ORANGE
ESSEX COUNTY, NJ

C A S E Y &

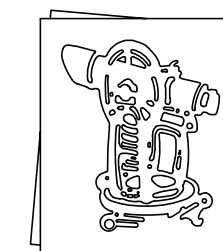

KELLER
INCORPORATED

NJ State Board of Professional Engineers & Land
Surveyors Certificate of Authorization # 24GA27985400

LICENSED PROFESSIONAL
CIVIL ENGINEERS
LAND SURVEYORS
PLANNERS

258 Main Street, PO Box 191
Millburn, New Jersey 07041
973-379-3280 Fax:973-379-7993

BRIAN S. CONWAY

DATE 01-24-14
New Jersey Licensed Landscape Architect No. AS00651

REFERENCE	MTL CHK. BY	PM DRAWN BY
2052 MAP NO.	CAD FIELD BOOK	DWG.NO.
1140108 JOB NO.	1"=30' SCALE	10

PLATE C No. 1

REVISIONS	